



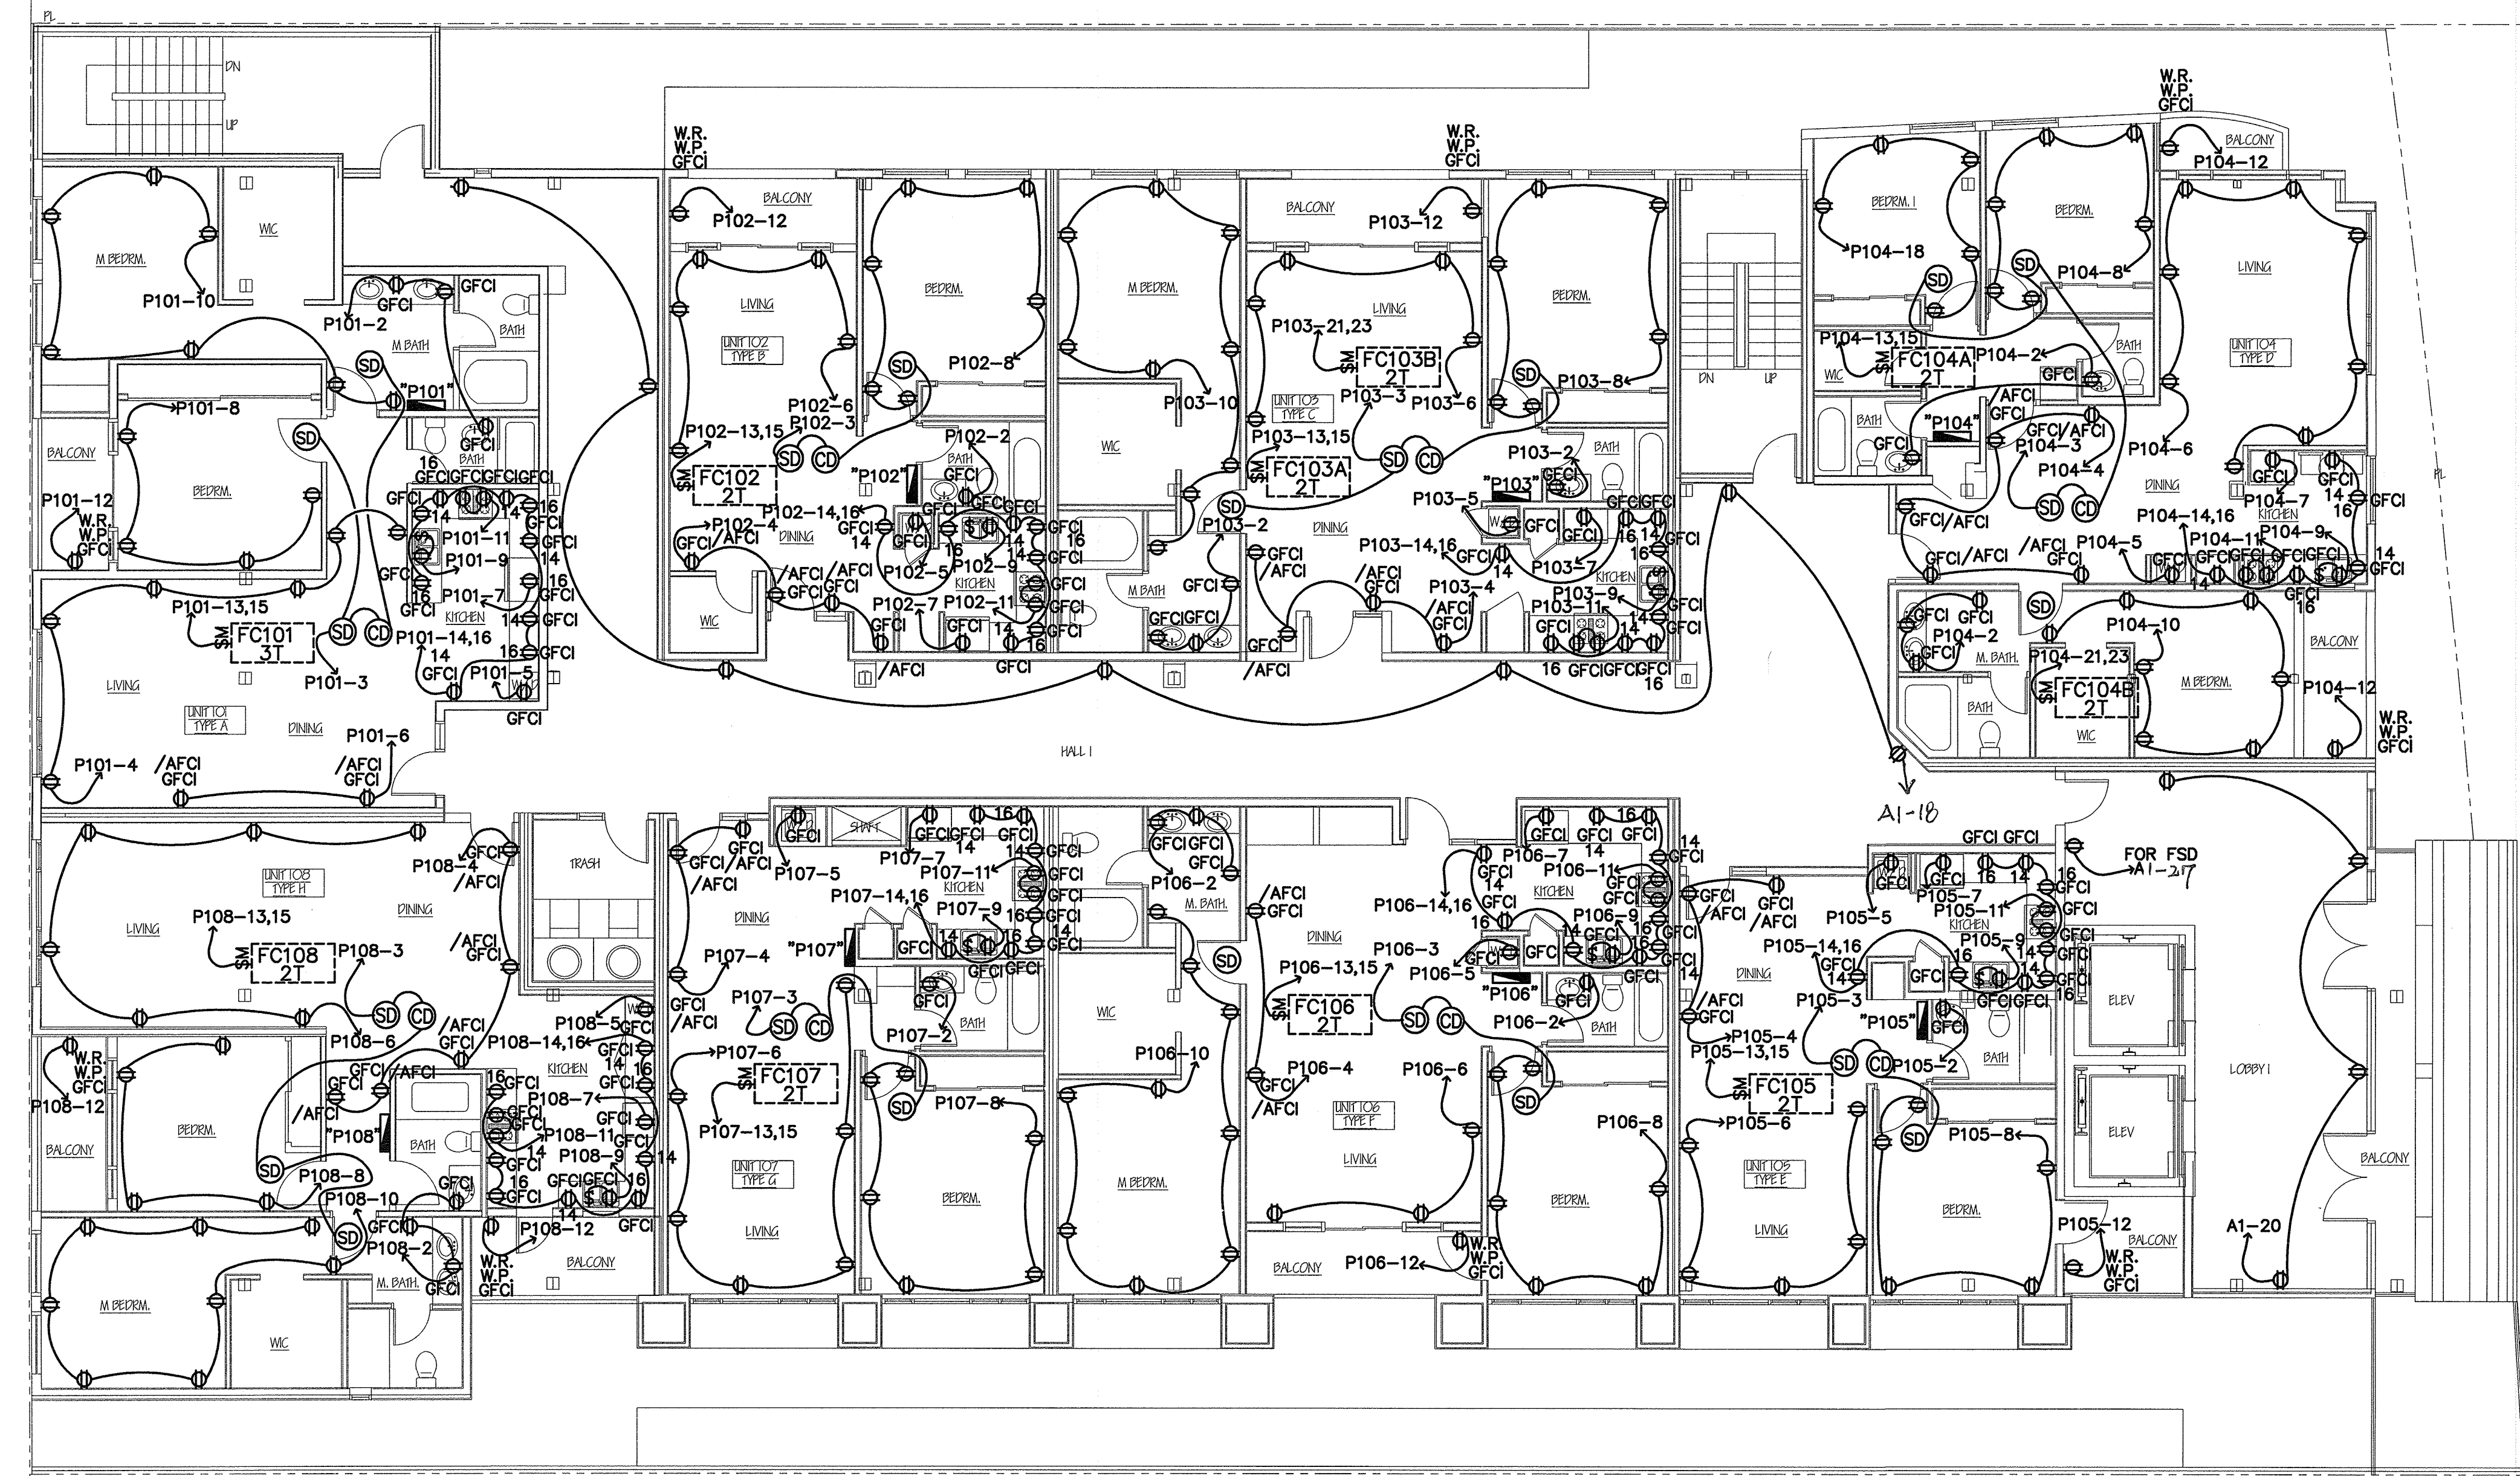

2ND FLOOR POWER PLAN  
1/8"=1'-0"

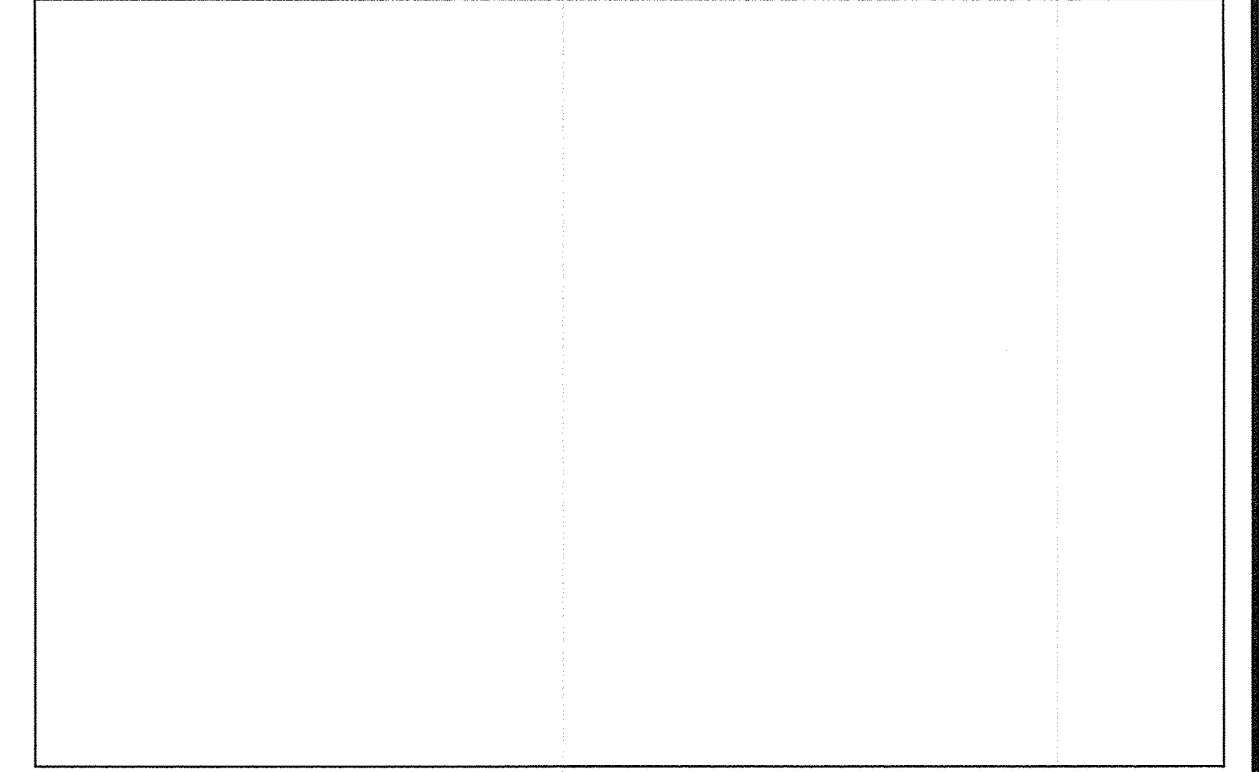

CITY STAMP LOCATION



REVISIONS BY

PERFECT DESIGN & INVESTMENT, INC.  
Design & Consulting  
Air-Conditioning, Plumbing, Fire Sprinkler System,  
Electrical, Title 24 Energy Calculation.  
2416 W. Valley Blvd.  
Alhambra, CA 91803  
Tel: (626) 286-8808  
E-Mail: PERFECTIAA@aol.com Fax: (626) 286-4913  
E-Mail: perfectiaa2@gmail.com

38 UNITS OF APARTMENT  
1815 - 1821 S BRAND  
GLENDALE, CA

Date 06-19-2020  
Scale  
Drawn J.F.  
Job # F20-1139  
Sheet  
**E-7**  
Of Sheets